



FIRE SIGNAGE LEGEND:

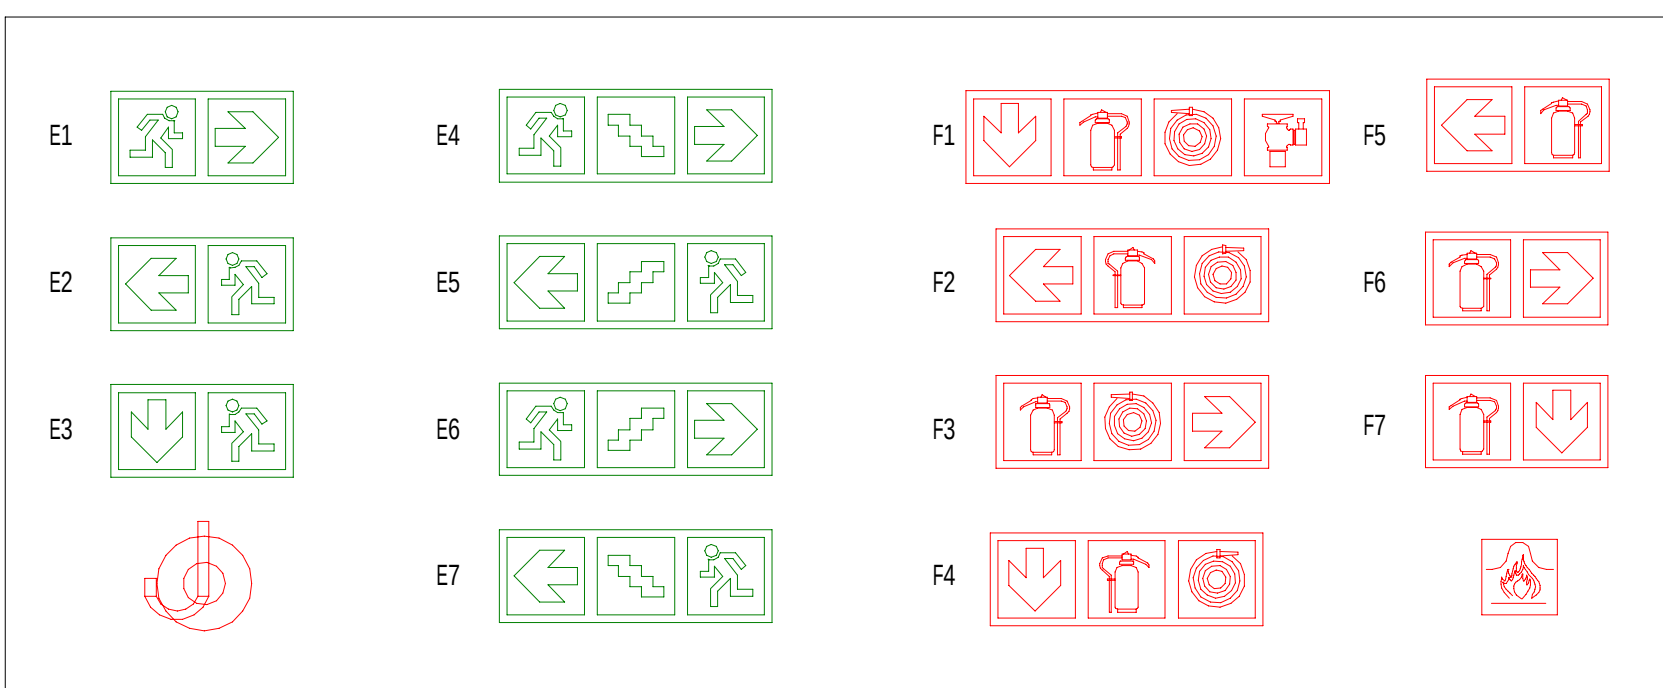

TYPICAL FIRE HYDRANT & HOSE REEL ASSEMBLY

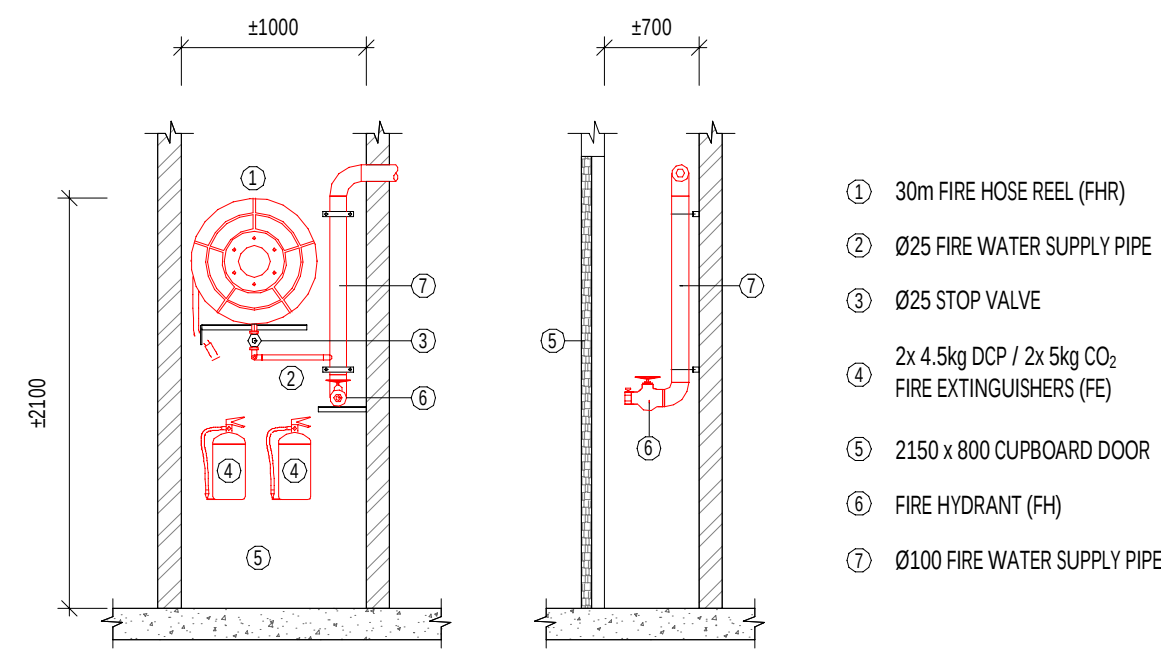

FIRE SIGNAGE NOTES:

- ALL FIRE SIGNAGE IS TO COMPLY WITH SANS 1156-5 PHOTO-LUMINESCENT SIGNAGE.
- SINGLE SIDED (S/S) SIGNS SHALL BE FIXED TO WALLS USING PLUGS AND STAINLESS STEEL HOUD AND HEAD SCREWS.
- DOUBLE SIDED (D/S) SIGNS SHALL BE HUNG FROM THE CEILING / ROOF USING LIGHTWEIGHT STAINLESS STEEL CABLE.
- DIMENSIONS OF FIRE SIGNAGE:
 - 1 ICON - 180 x 180
 - 2 ICONS - 190 x 384
 - 3 ICONS - 190 x 570



GENERAL NOTES:

- ALL WORK TO COMPLY WITH LOCAL FIRE DEPARTMENT REQUIREMENTS & SANS 10400.
- EXTINGUISHERS TO BE INSTALLED IN ACCORDANCE WITH SANS 10400. HOSE REELS TO BE INSTALLED IN ACCORDANCE WITH SANS 10400. HYDRANTS TO BE INSTALLED IN ACCORDANCE WITH SANS 1128.
- PORTABLE FIRE EXTINGUISHERS TO BE HUNG ON PURPOSE MADE BOARDS & LOCATED IN SECURE POSITIONS AS INDICATED ON PLAN.
- ACCESS DOORS & ESCAPE DOORS IN ANY EMERGENCY ROUTE MAY ONLY BE FITTED WITH LOCKING DEVICES AS APPROVED BY THE LOCAL AUTHORITY.
- CLASS FIRE DOORS 900mm WIDE TO COMPLY WITH SANS 1253 & TO BE FITTED WITH APPROVED SELF CLOSING OR AUTOMATIC CLOSING DEVICES.
- EMERGENCY LIGHTING TO BE INSTALLED TO ALL ESCAPE ROUTES.
- MARKING & SIGNAGE TO COMPLY WITH SANS 1196. PICTORIAL SIGNS INDICATING FIRE EQUIPMENT & MEANS OF ESCAPE TO BE PROVIDED. ALL SIGNAGE WILL BE PHOTO-LUMINESCENT.
- SUSPENDED CEILING & ITS SUPPORTING MEMBERS TO BE NON-COMBUSTIBLE.
- STRUCTURAL ELEMENTS AND COMPONENTS TO COMPLY WITH SANS 10400-1.
- ALL EXPOSED FIRE PIPES TO BE PAINTED RED.

SITE SPECIFIC NOTES:

- OCCUPANCY CLASS G1 - CONSULTING ROOMS.
- SEE DEEMED TO SATIFY FIRE REPORT

FIRE PROTECTION LEGEND:

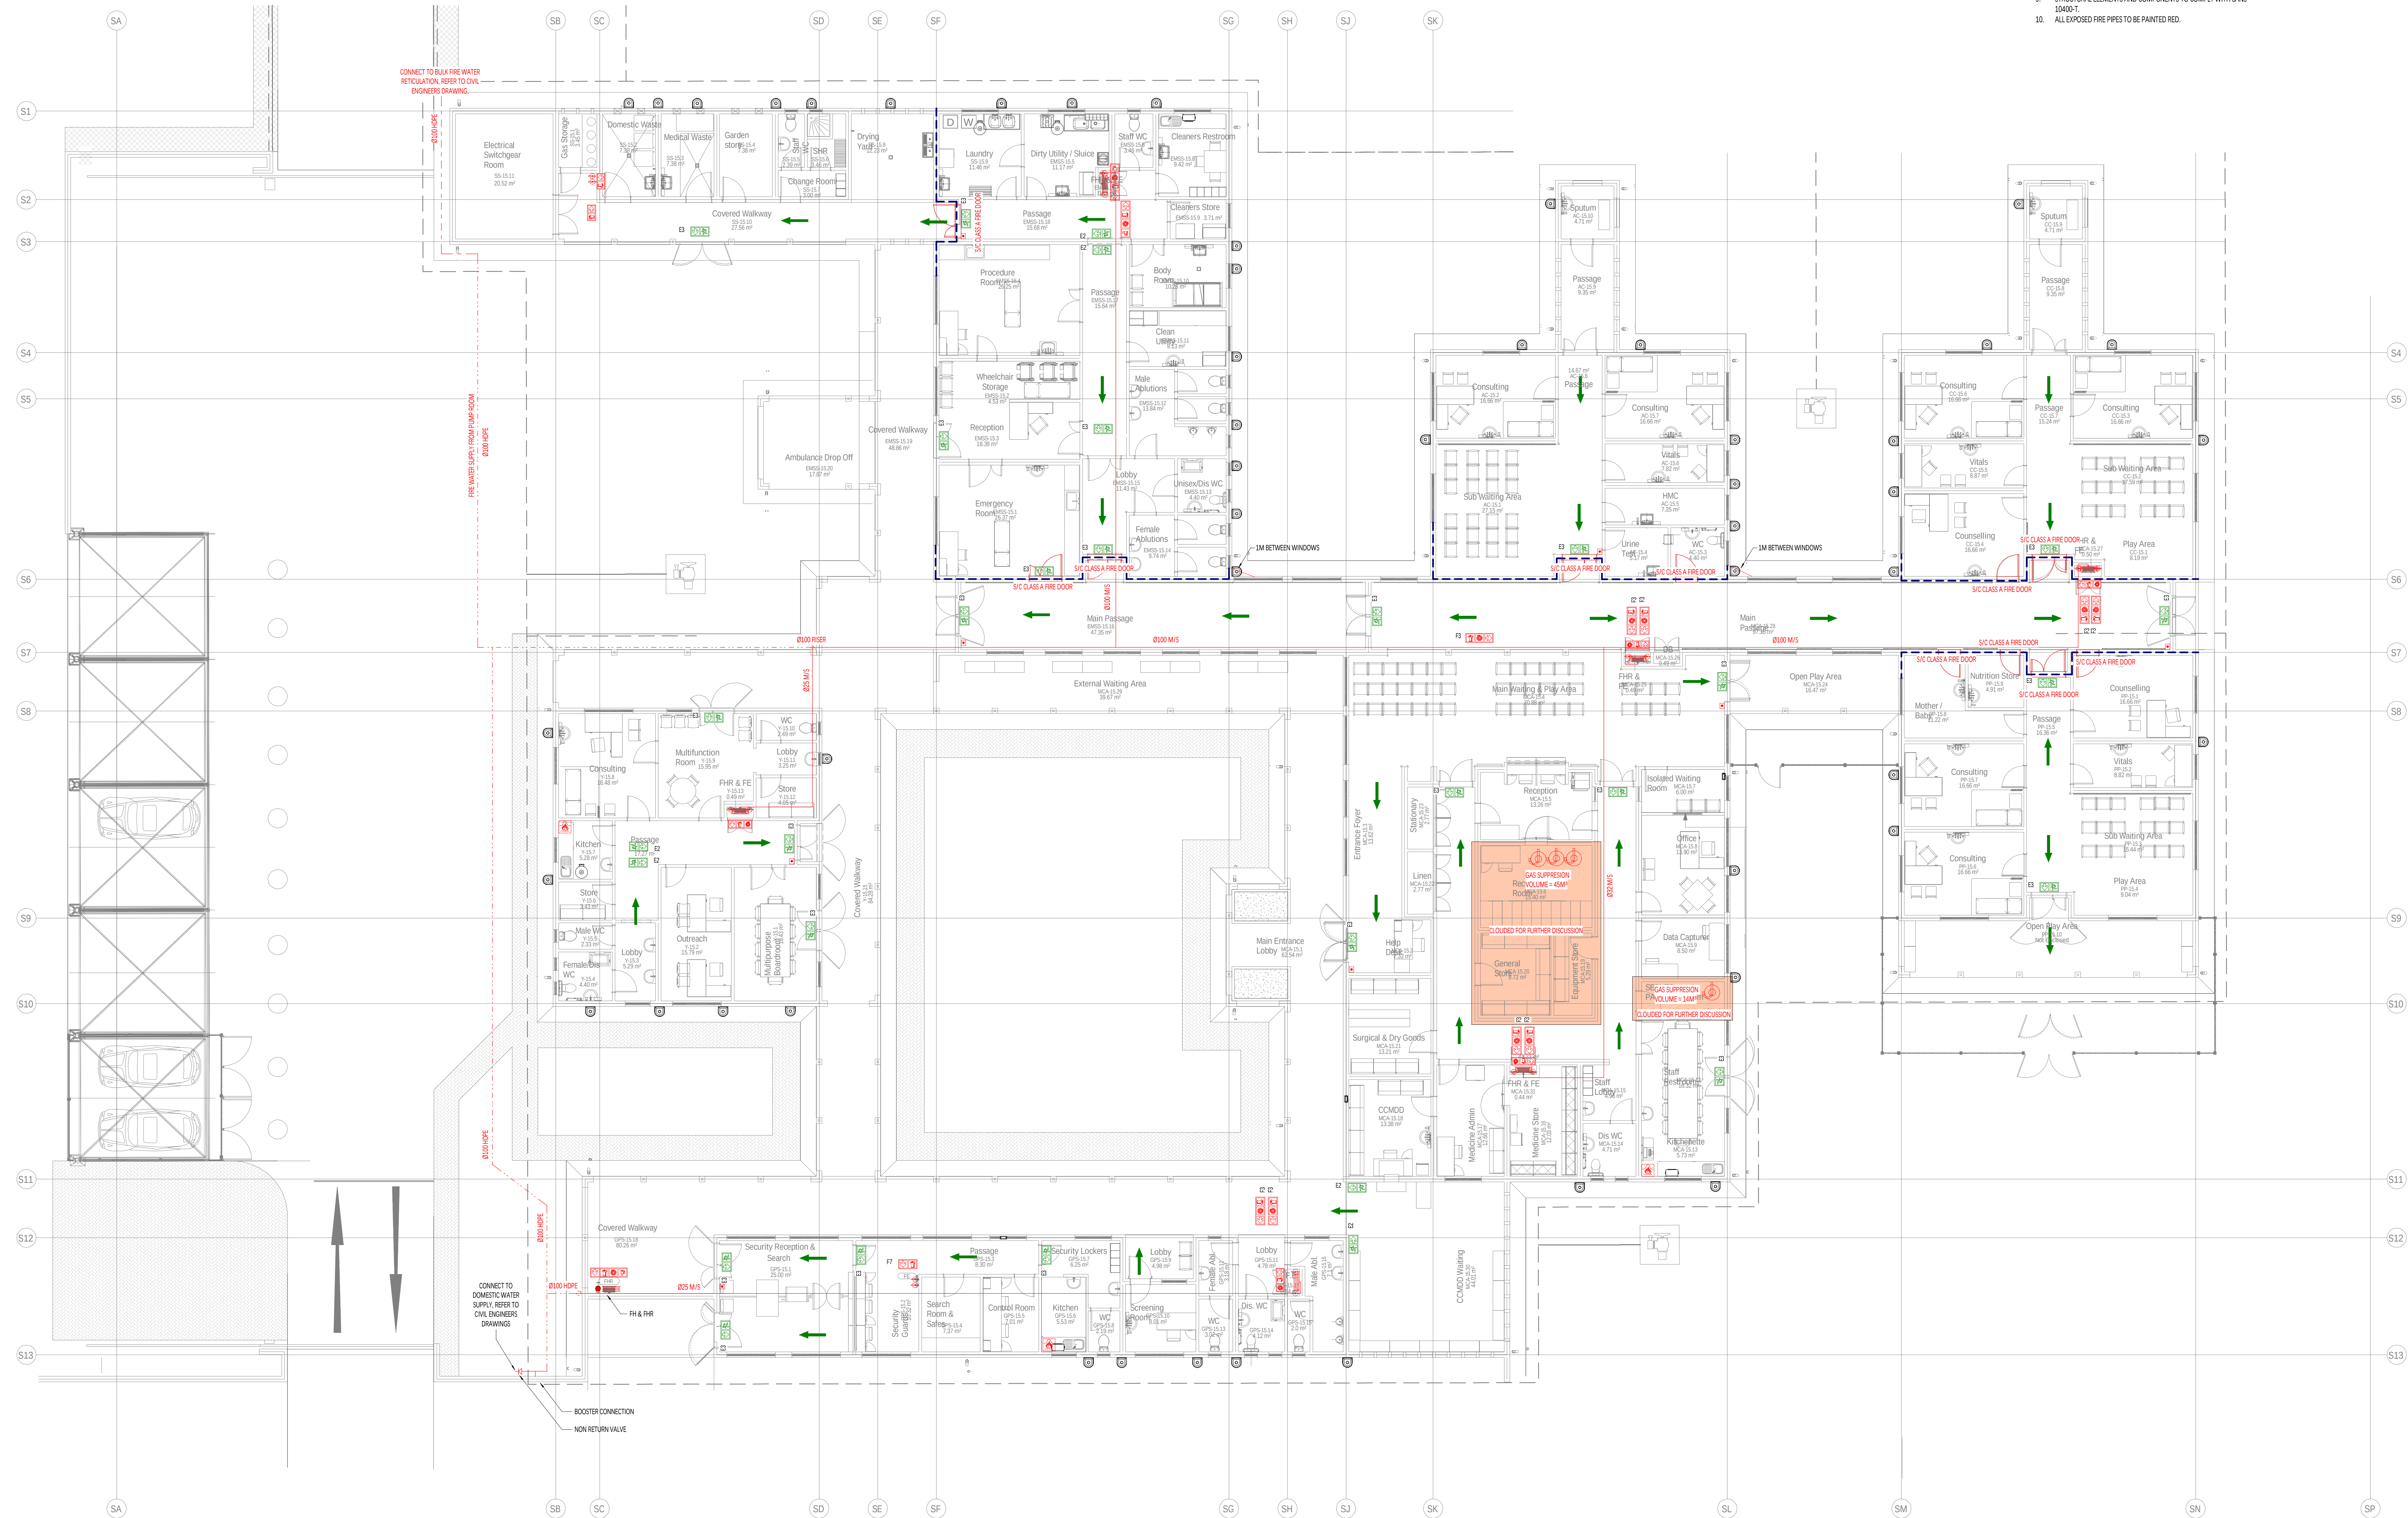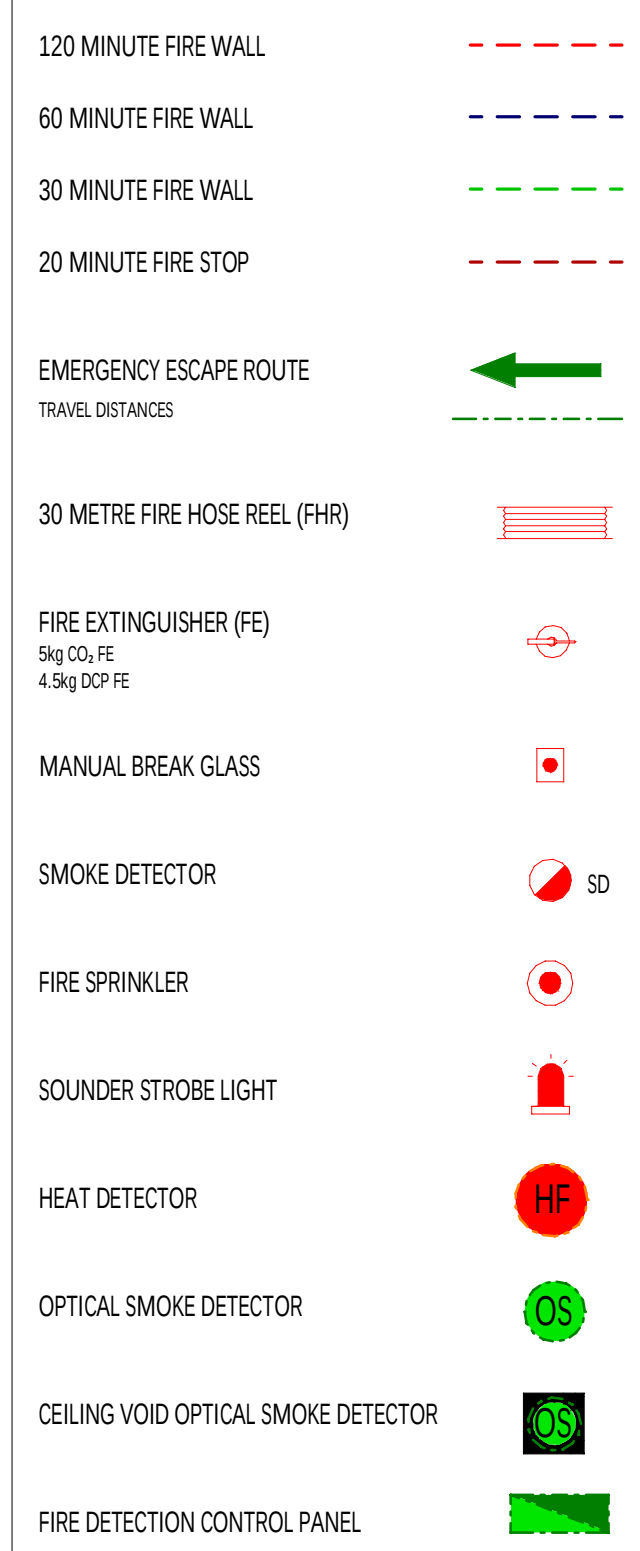

GROUND FLOOR FIRE PROTECTION
PLAN
1:100

F 2024-08-14 S.M. ISSUED FOR TENDER	
E 2024-07-08 S.M. HAC STAGE 4	
D 2024-05-24 S.M. REVISED TO LATEST ARCHITECTURAL LAYOUT	
C 2024-04-18 S.M. REVISED HAC SUBMISSION	
B 2024-03-28 S.M. REVISED HAC SUBMISSION	
A 2023-11-16 S.M. HAC SUBMISSION	
REV	DATE BY DESCRIPTION
If drawing status = construction, a signed copy of this drawing (either in hardcopy or electronic format) is available at the office of origin and at the office of issue.	
DRAWING STATUS: TENDER	
CLIENT: DEPARTMENT OF HEALTH	
ARCHITECT: INCLINE ARCHITECTS	
PROJECT: THULASIZWE CLINIC	
TITLE: GROUND FLOOR FIRE PROTECTION PLAN	
SCALE @ A0: As indicated	CHECKED: R.G. APPROVED: N.K.
DESIGN: J.L.	DRAWN: S.M. DATE: 2024-08-14
PROJECT No: D0741	DRAWING No: D0741-FP-01 Rev: F
© COPYRIGHT RESERVED	